


P R O P O S E D

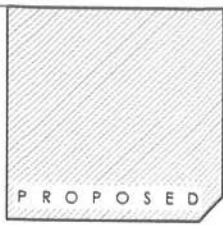


Proposed Alterations & Additions

'ATHOL 02 LODGE EXTENSIONS'

7 DIGGINGS TERRACE, THREDBO

Lot 756 DP 1119757

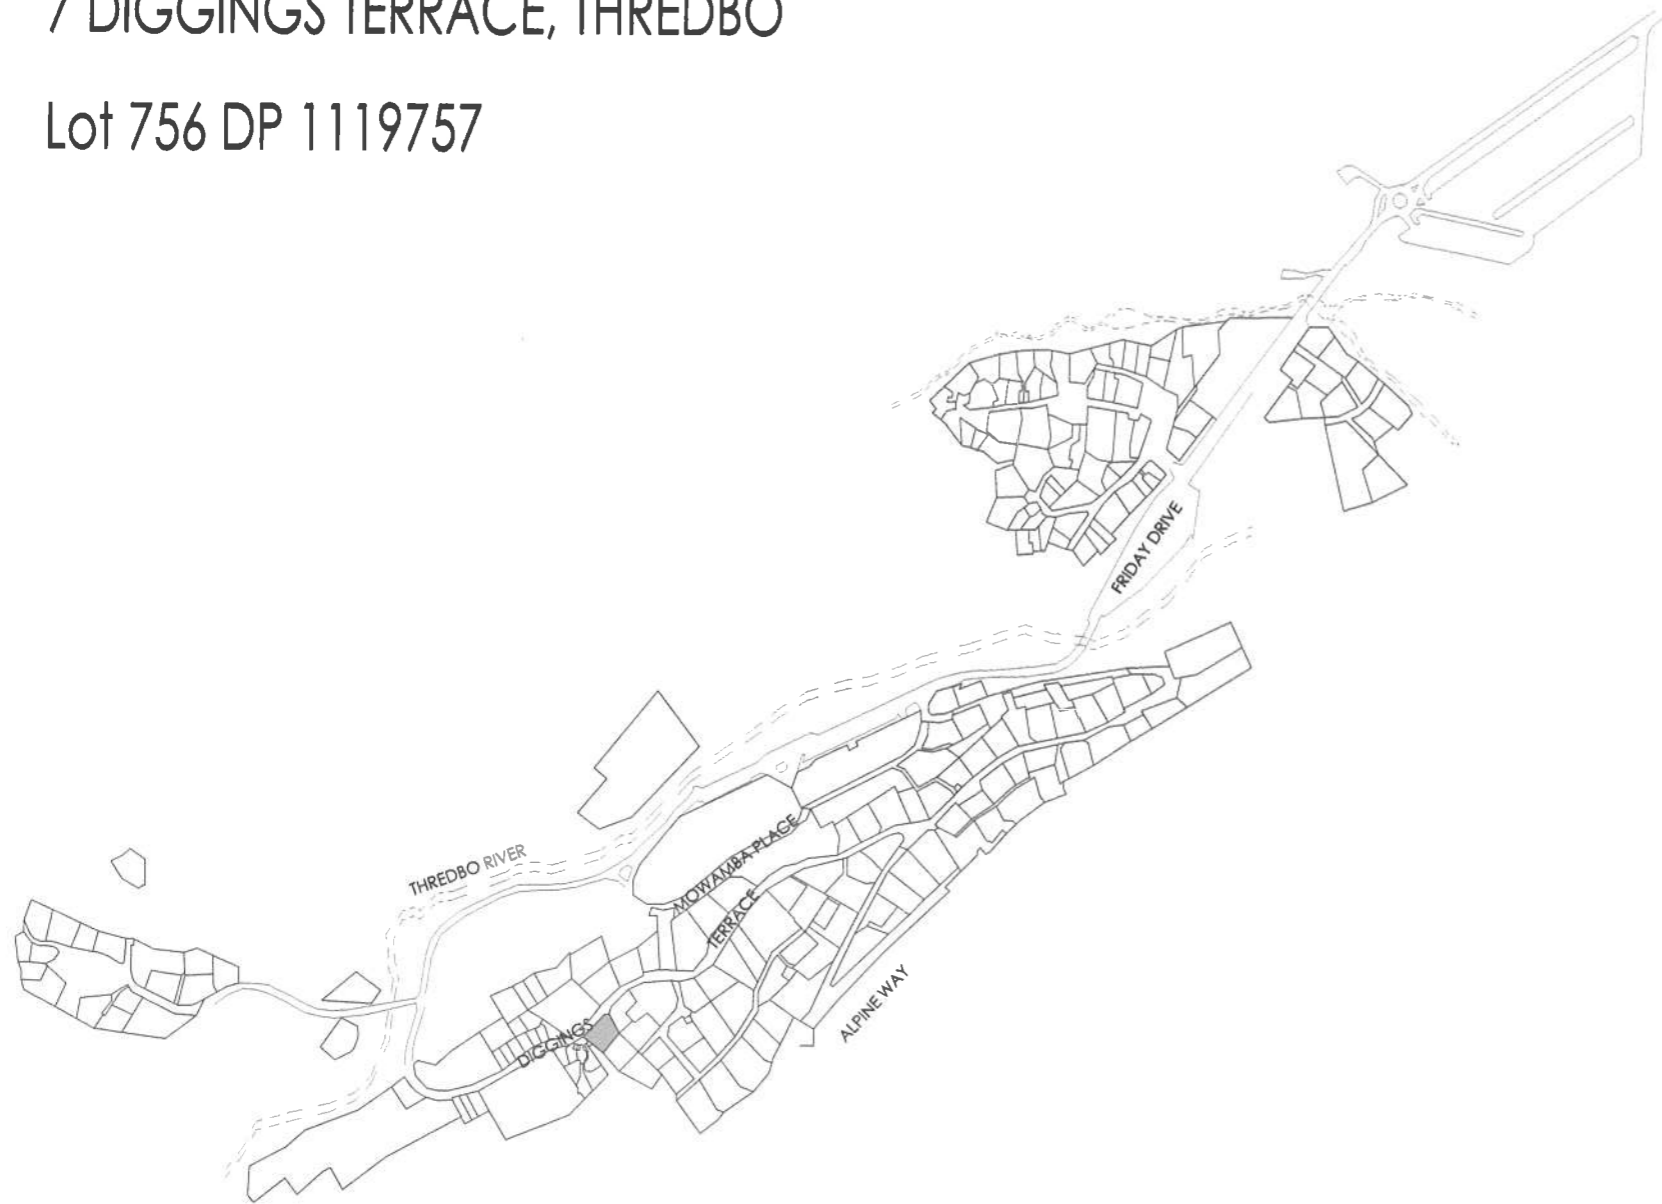

LOCALITY PLAN
NTS

SK - 00 DRAWING REGISTER

SK - 01 EXISTING PLANS 01

SK - 02 EXISTING PLANS 02

SK - 03 DEMOLITION PLAN

SK - 04 PROPOSED SITE PLAN

SK - 05 PROPOSED GROUND FLOOR PLAN

SK - 06 PROPOSED FIRST FLOOR PLAN

SK - 07 PROPOSED SECOND FLOOR PLAN

SK - 08 PROPOSED THIRD FLOOR PLAN

SK - 09 PROPOSED ELEVATIONS 01

SK - 10 PROPOSED ELEVATIONS 02

SK - 11 SECTIONS

SK - 12 JOINERY DETAILS 01


SK - 13 JOINERY DETAILS 02

SK - 14 ELECTRICAL PLAN

SK - 15 FLOOR FINISHES SCHEDULE

SK - 16 BALUSTRADE DETAIL

SK - 17 WINDOW SCHEDULE

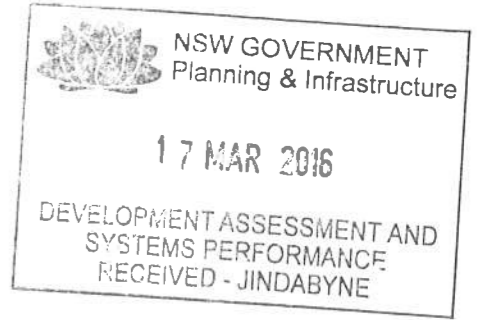

Drawing No	SK - 00	Scheme One		
Date	MAY 2015	Scale	N.T.S.	
Revision	09			
Drawn	LP	Checked	Approved	Status
		LP	MO	TOWN PLANNING